


Section S2

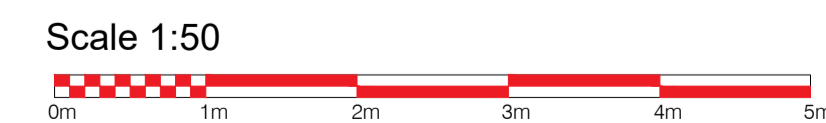

NOTES

ABBREVIATIONS

A/C	Air Conditioner	HT	Height
AB	Air Brick	IC	Inspection Cover
BK	Brick	IL	Invert Level
BO	Bollard	I/R	Iron Railings
BS	Bus Stop	JB	Junction Box
BT	British Telecom cover	KO	Kerb Outlet
FC	Floor to Cill height	LP	Lamp Post
CL	Cover Level	LW	Light Well
CO	Column	MH	Manhole
CONC	Concrete	MT	Meter
CPL	Coping Level	OH	Overhead
CPS	Concrete Paving Slabs	PT	Post
CTV	Cable Television Cover	RET	Retaining
DK	Drop Kerb	RS	Road Sign
DH	Door Height	RWP	Rain Water Pipe
EP	Electricity Pole	SVP	Soil Vent Pipe
FB	Flower Bed	TCB	Telephone Call Box
FC	False Ceiling	TBM	Temp. Bench Mark
FE	Fire Escape	TL	Traffic Light
FH	Fire Hydrant	TK	Tank
FHR	Fire Hose Reel	UTL	Unable To Lift
FL	Floor Level	V	Vent
GP	Gate Post	VP	Vent Pipe
GU	Gully	WM	Water Meter
GV	Gas Valve	WP	Waste Pipe
CH	Cill to Head height	WV	Water Valve

CO-ORDINATE SYSTEM

- GRID
- Arbitrary - related to building line
 - Arbitrary - approx. related to North
 - Ordnance Survey National Grid
- LEVELS
- Arbitrary - related to a temporary bench mark
 - Ordnance Survey Bench Mark
 - Ordnance Survey National GPS Network

Rev	Date	By	Details

FLOOR PLAN SYMBOLS

- +20.00 Spot Level
- (2.80) Ceiling Height
- (F2.80) Floor To False Ceiling Height
- BH 2.80 Floor To Beam Height
- FC 0.80 Floor To Cill Height/Cill To Head Height
- CH 1.90 Floor To Cill Height/Cill To Head Height
- (20.00) Ceiling Level
- (F20.00) False Ceiling Level



www.redlaserscanning.co.uk
 enquiry@redlaserscanning.co.uk
 London Head Office
 23 Sussex Street
 SW1V 4RR
 0207 477 2175

Project
 Little Gregories
 CM16 7JP
 Theydon Bois

Description
 Section S2

Survey Date 20/08/2021	Drawing Date 23/09/2021
---------------------------	----------------------------

Sheet @A1	Scale 1:50
--------------	---------------

Drawn AH	Checked CT
-------------	---------------

Project No. 1312	Drawing No. 11	Preliminary	Revision
---------------------	-------------------	-------------	----------